


Docket No. 7156
 Exhibit UPC-CRV-Reb6
 Admitted:

 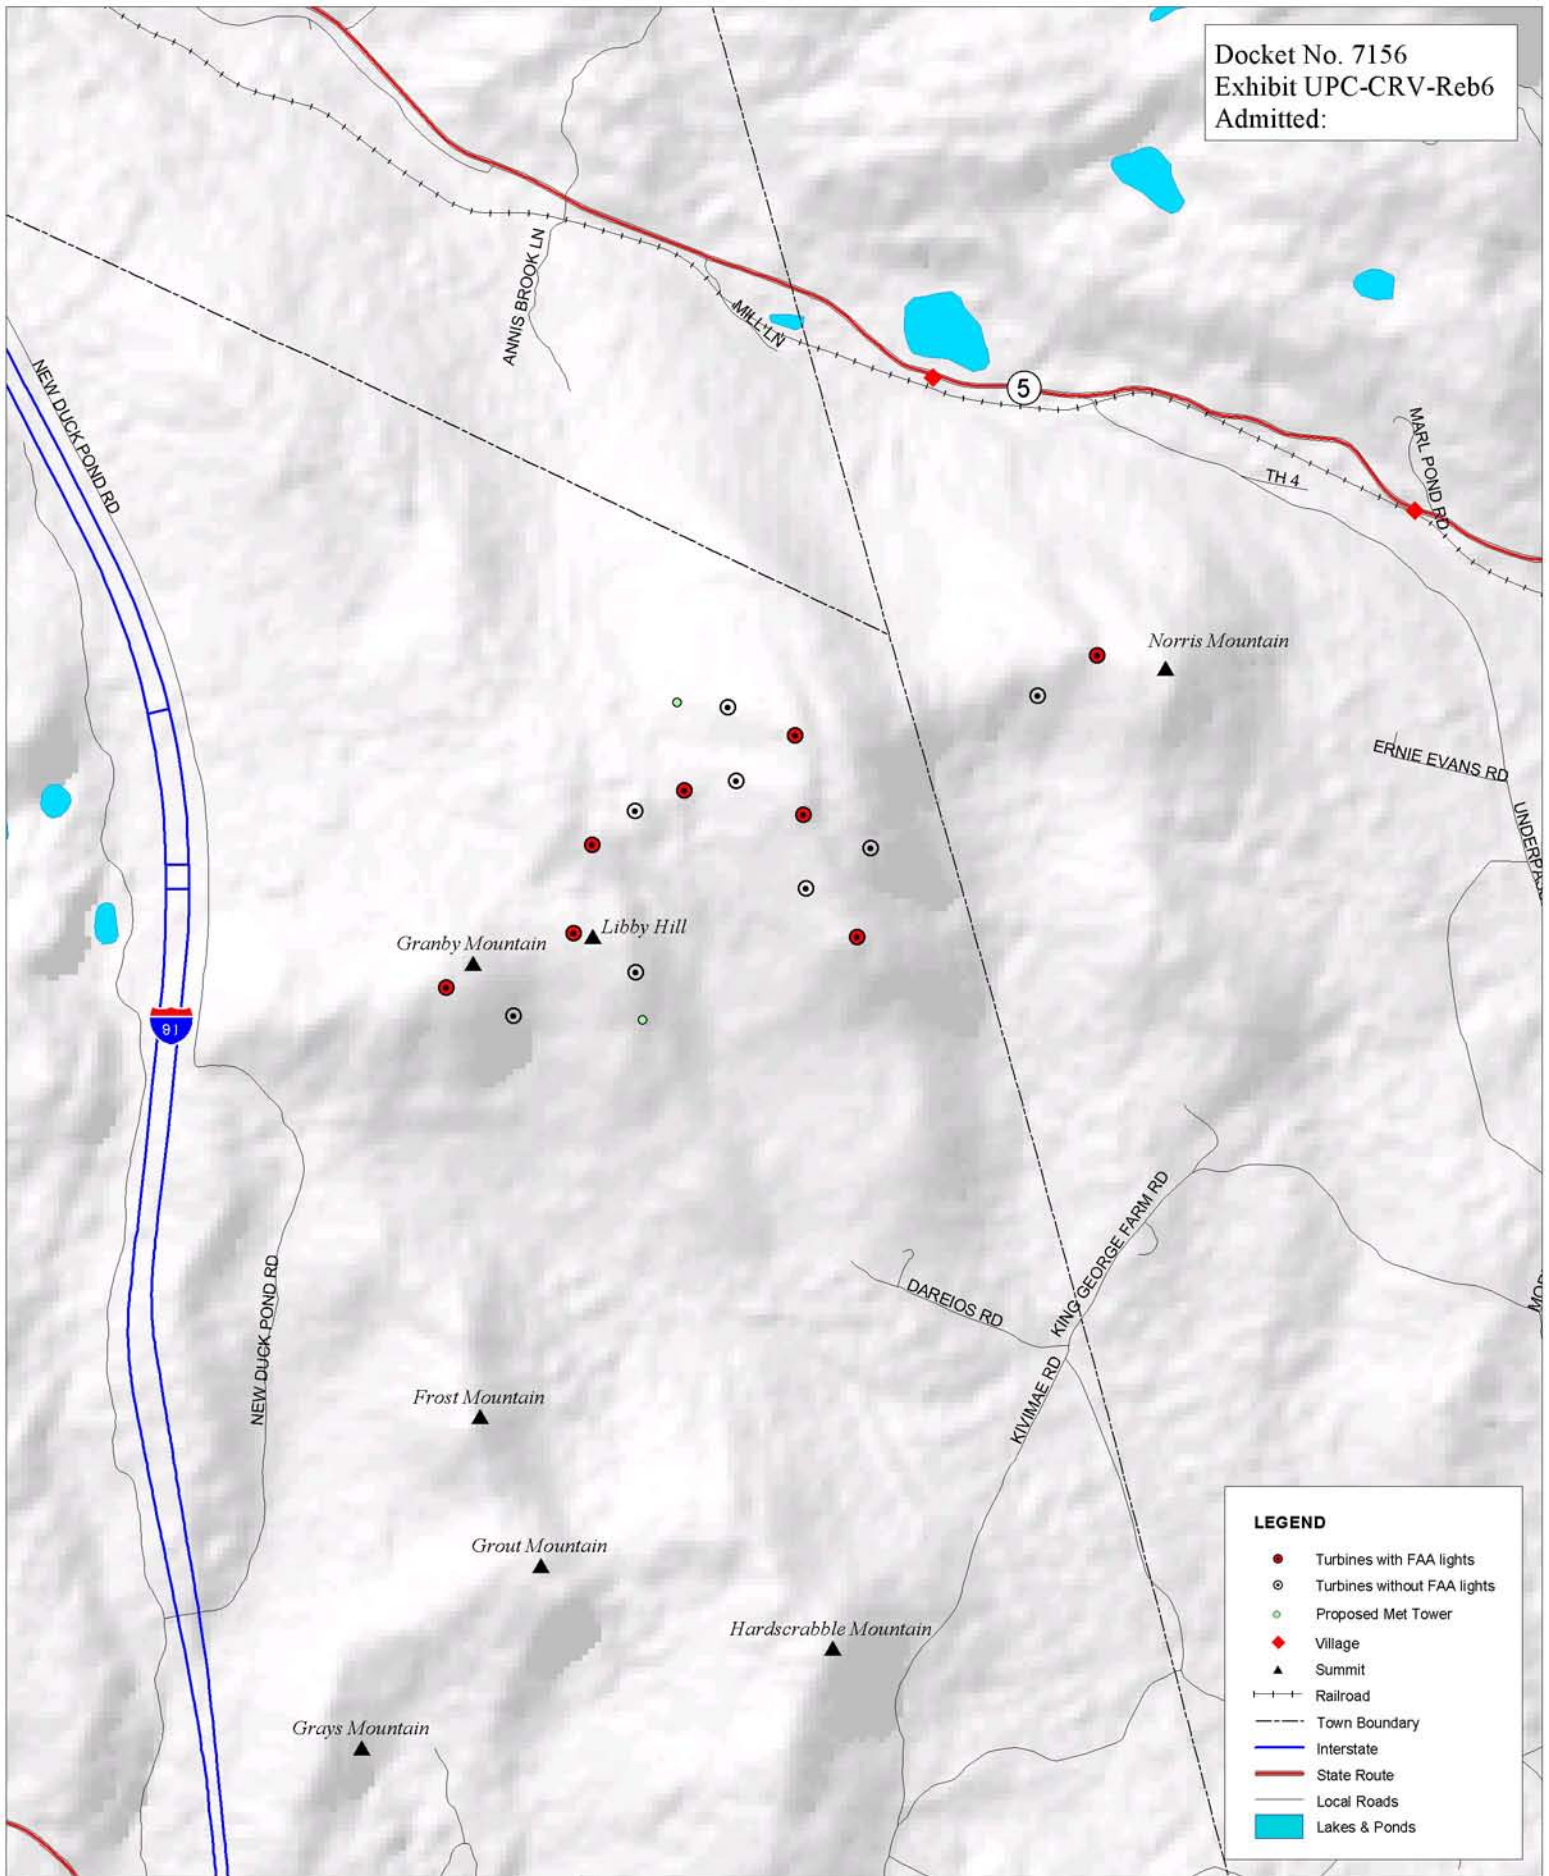


SHEFFIELD WIND FARM Lighting Plan Proposed to FAA Revised Turbine Layout

- Lighting layout based on revised DRAFT FAA guidelines.
 - Turbine location data provided by UPC.
 - All other data is based on GIS data available at the time from VCGI.
 - Data is only as accurate as original source, and is not guaranteed by LandWorks.

UPC Vermont Wind, LLC

Scale 1 in. = 3000 ft.



Prepared by LandWorks
 Middlebury, VT

DATE: 9/21/06
 DRAWN BY: NS